


GROUND FLOOR PLAN


SCHEDULE OF DOORS WINDOWS AND VENTILATORS				
NO.	TYPE	DESCRIPTION	QTY	REMARKS
1
2
3
4
5
6
7
8
9
10
11
12
13
14
15
16
17
18
19
20

CENTRE FOR DISTANCE EDUCATION BUILDING
FOR ACHARYA NAGARJUNA UNIVERSITY CAMPUS AT GUNTUR

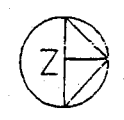

DRG NO 0403SF
SCALE 1:100
DLT:
DATE: 26-12-05

B A
S E ASSOCIATES
ARCHITECTS & STRUCTURAL ENGINEERS
First Floor, Opp to Shalimar Theater,
Narayanaguda, Hyderabad.
Telephone no 040-55734552, 24754552

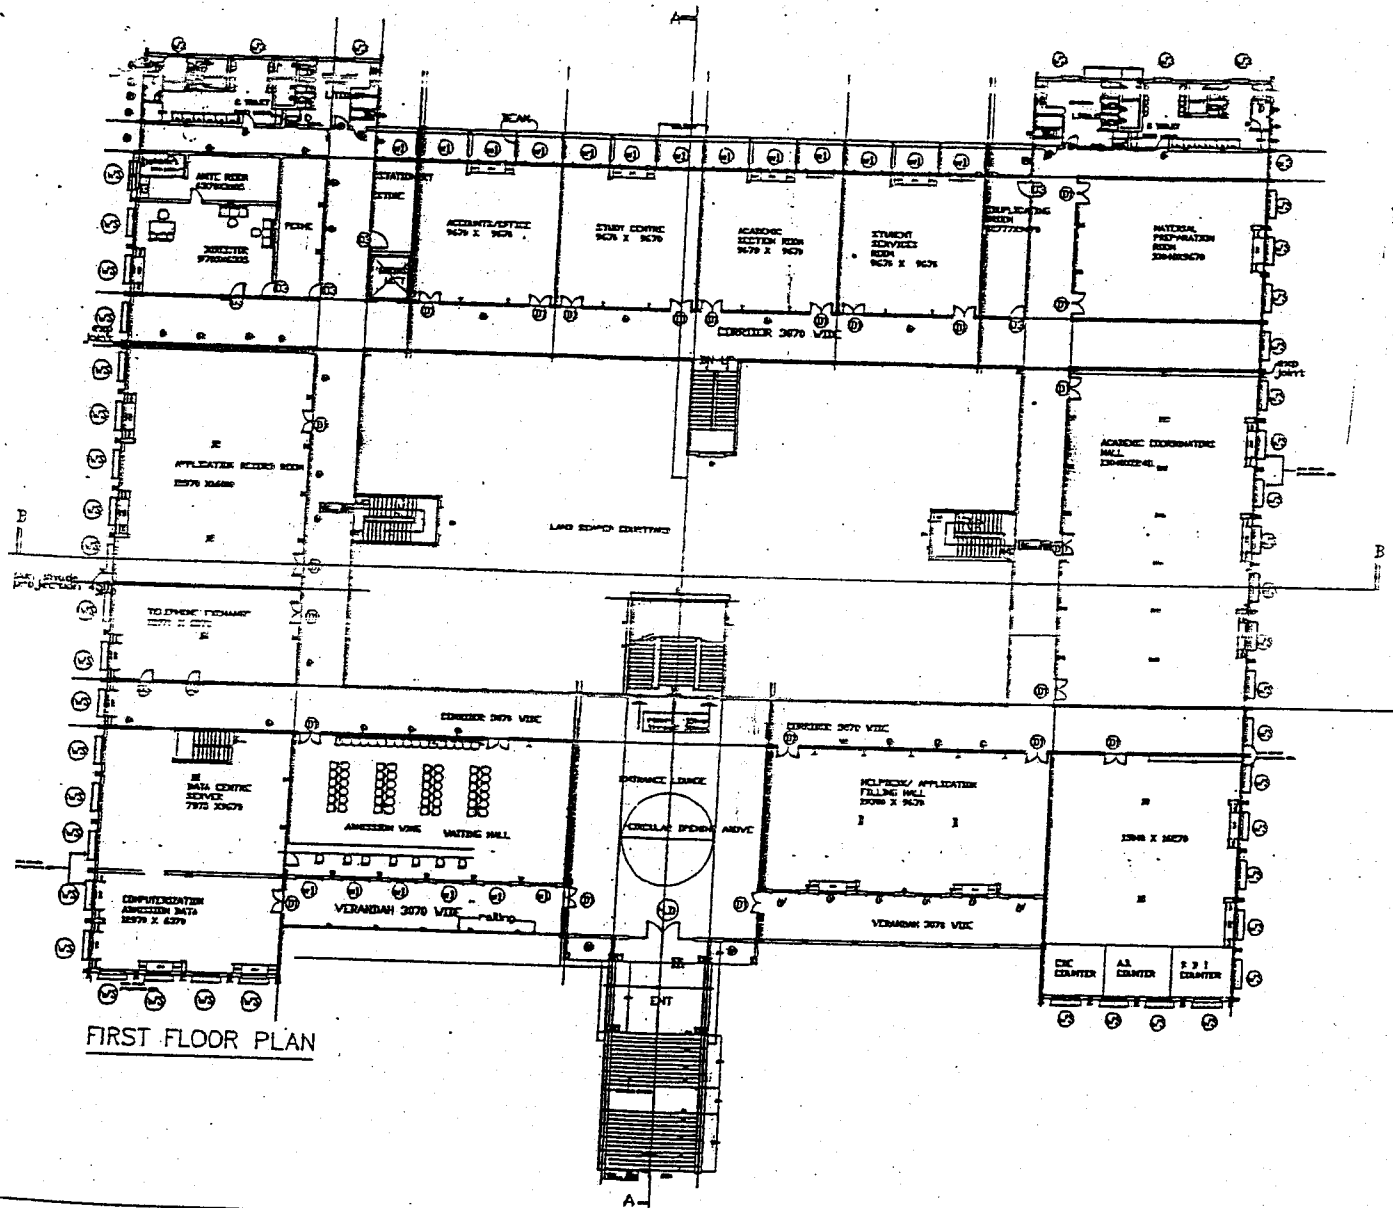


FIRST FLOOR PLAN

CENTRE FOR DISTANCE EDUCATION BUILDING
 FOR ACHARYA NAGARJUNA UNIVERSITY CAMPUS AT GUNTUR



DRG NO D40.3SF
 SCALE 1:100
 DLT:
 DATE: 26-12-05

B A
S E ASSOCIATES
 ARCHITECTS & STRUCTURAL ENGINEERS
 First Floor ,Opp to Shalimar Theater,
 Narayanaguda, Hyderabad.
 Telephone no 040-55734552,24754552

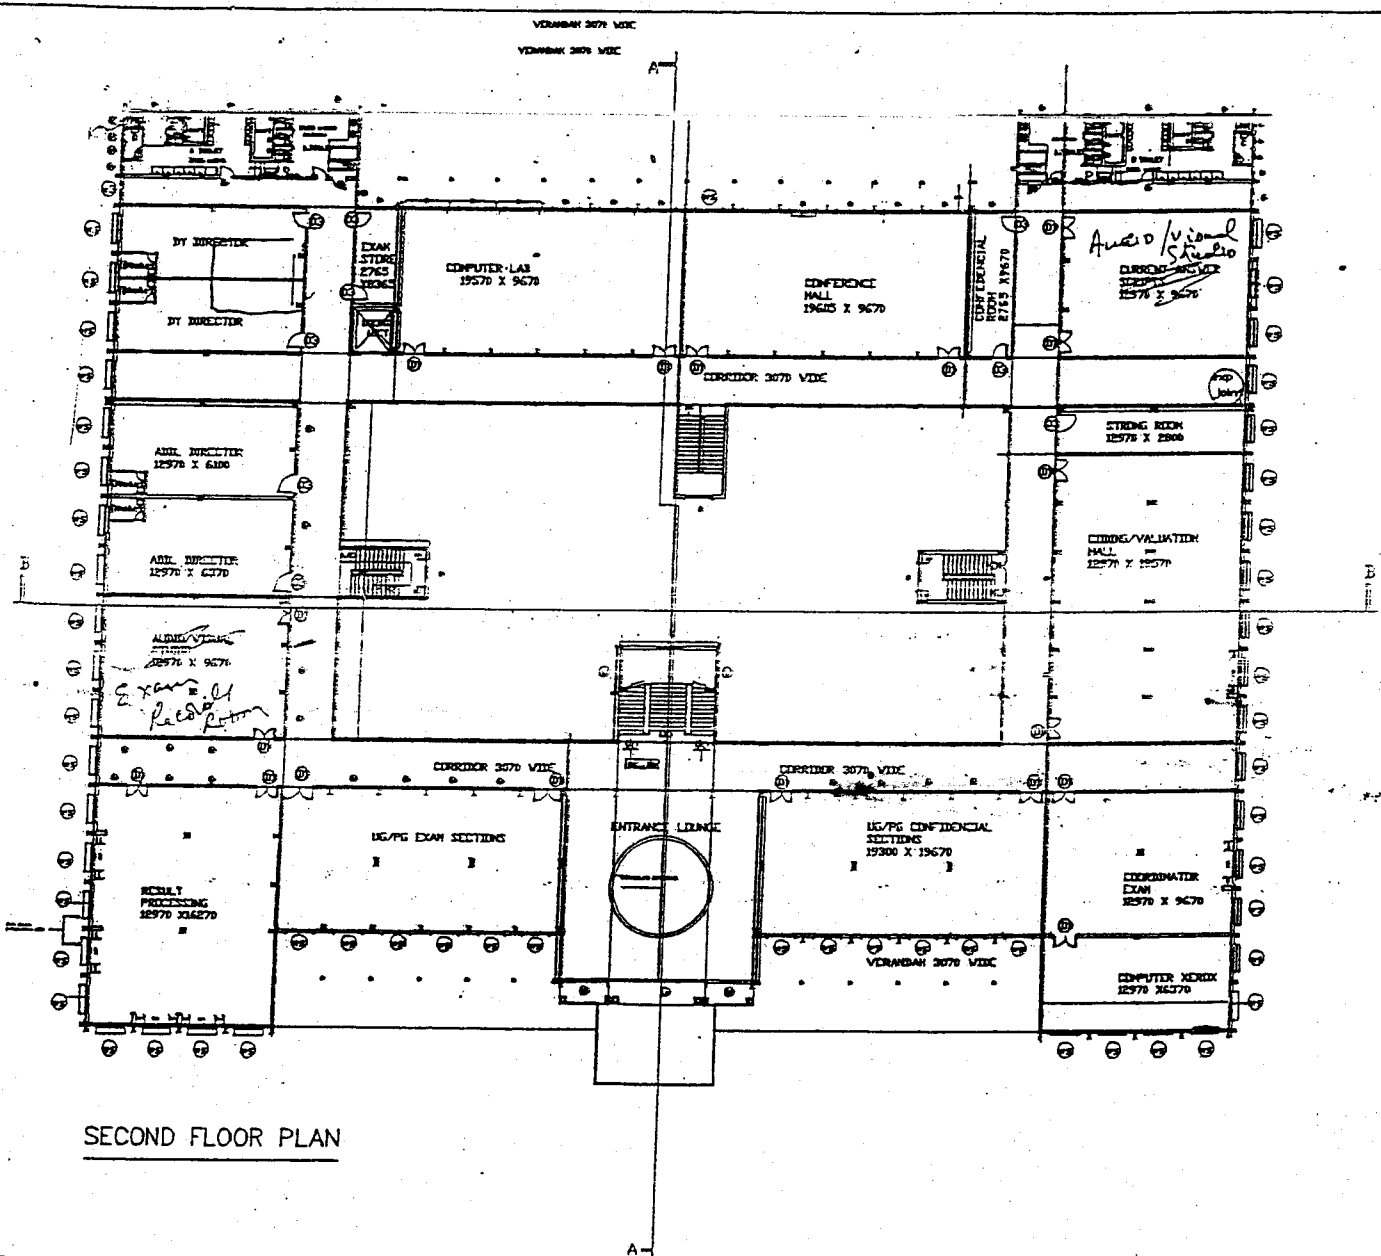

SECOND FLOOR PLAN

CENTRE FOR DISTANCE EDUCATION BUILDING
 FOR ACHARYA NAGARJUNA UNIVERSITY CAMPUS AT GUNTUR



DRG NO 04.03SF
 SCALE 1:100
 DLT:
 DATE: 26-12-05

B A S E ASSOCIATES
 ARCHITECTS & STRUCTURAL ENGINEERS
 First Floor, Opp to Shalimar Theater,
 Narayanaguda, Hyderabad.
 Telephone no 040-55734552, 24754552